

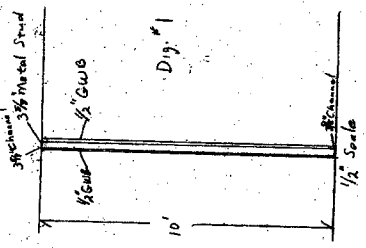



135 KING ST


135 KING ST Northampton, Ma.  
 FLOOR PLAN FOR EXISTING

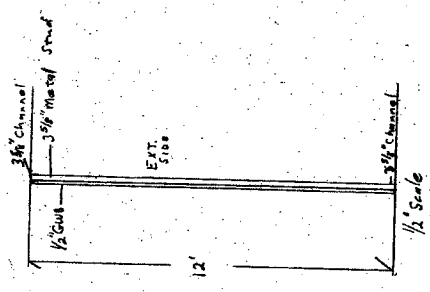

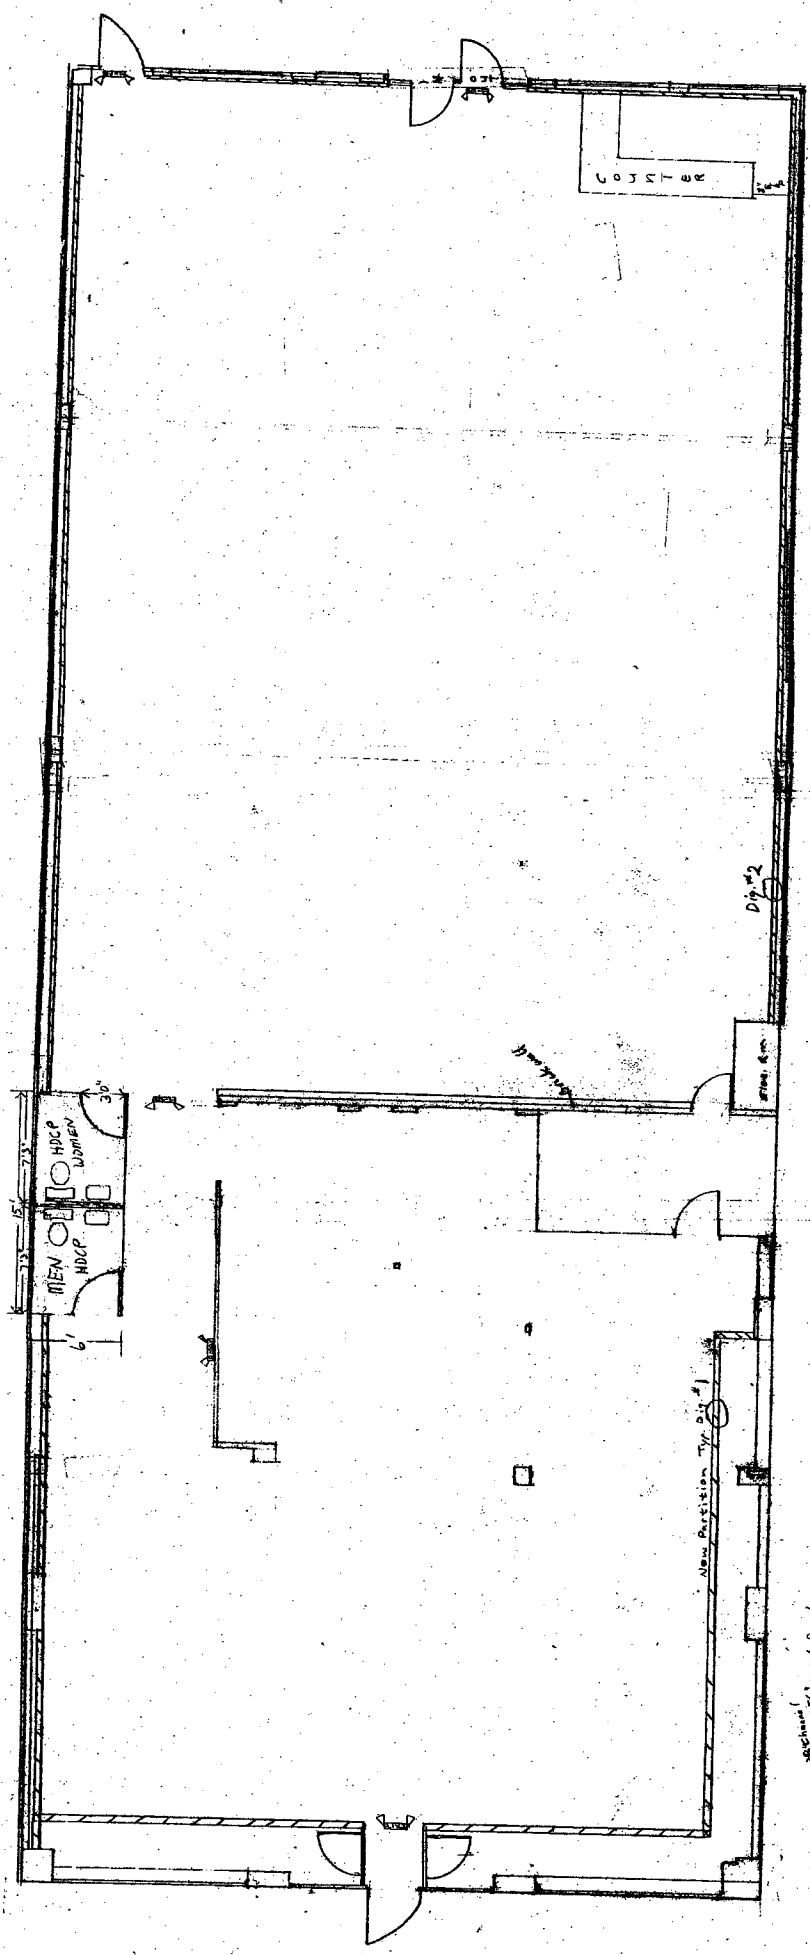

135 KING ST. Northampton, Ma.  
 SCALE: 1/8" = 1'-0" DRAWN BY: J.S.V.  
 DATE: 05  
 New Partitions & HACP Restrooms

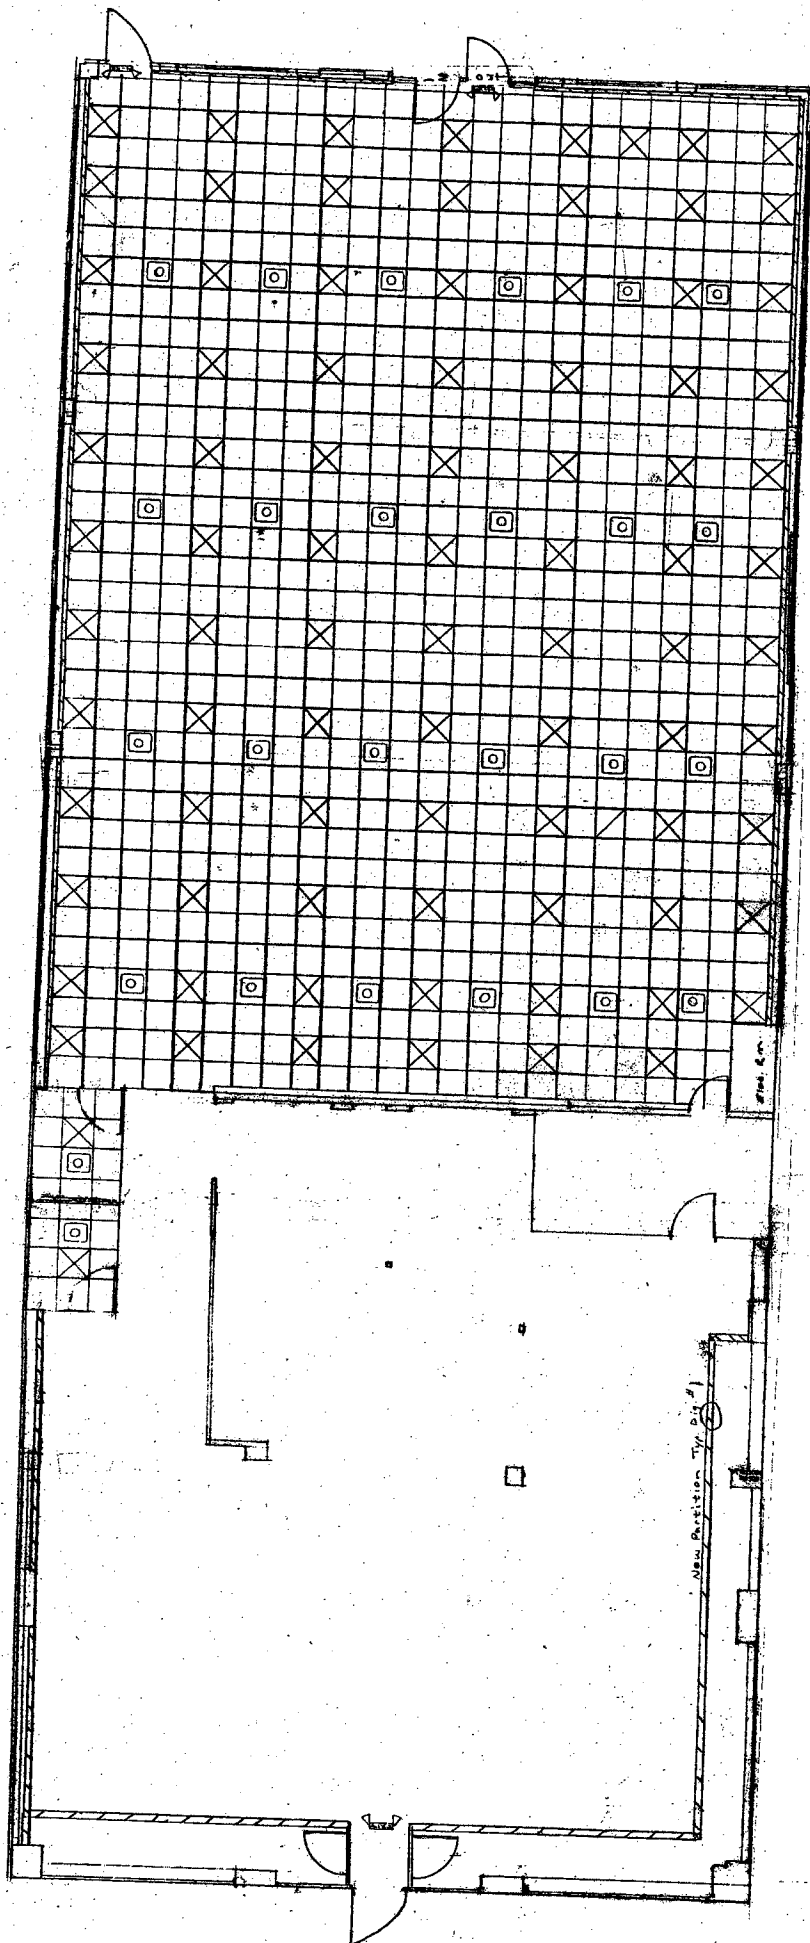



 2x2 Lay-in  
Fluorescent  
Light  
Energy Saving

 Air Supply Register

 Suspended Ceiling  
Acoustic Grids  
2x2 Lay-in  
Grid & Plane Spread

Reflected Ceiling  
Plan

135 KING ST. Northampton, Ma.	
Scale: 1/4" = 1'-0"	Version: 1.1
Drawn: Z.S./D.L.	Checked: B.E./V
Reflected Ceiling Plan	
Sheet No. 3	